





1 LEVEL 1
SCALE: 1/4" = 1'-0"

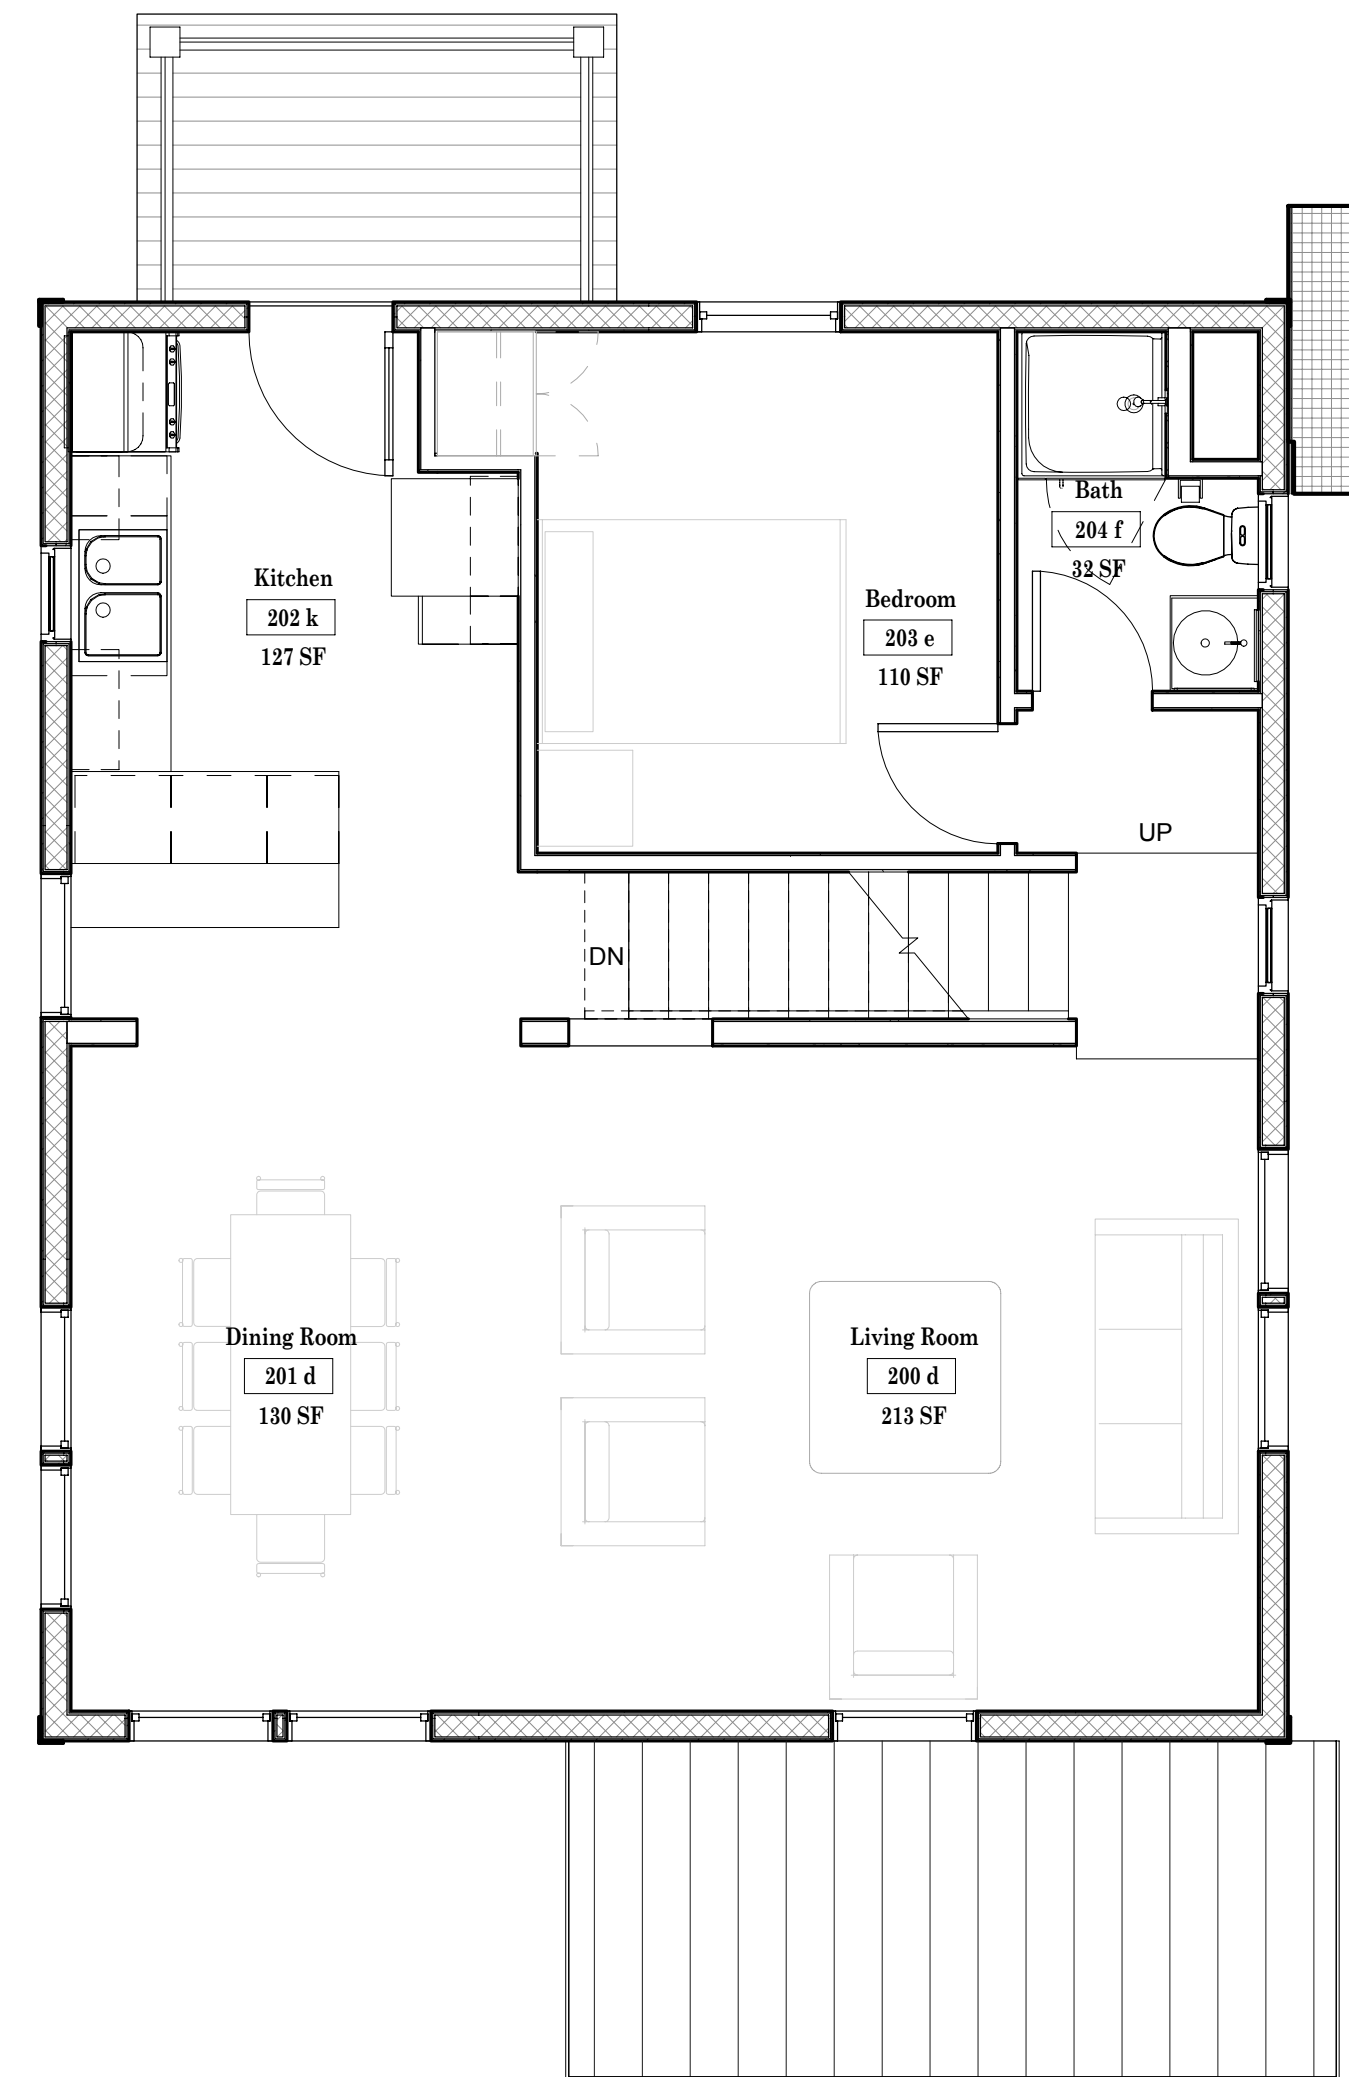

2 LEVEL 2
SCALE: 1/4" = 1'-0"

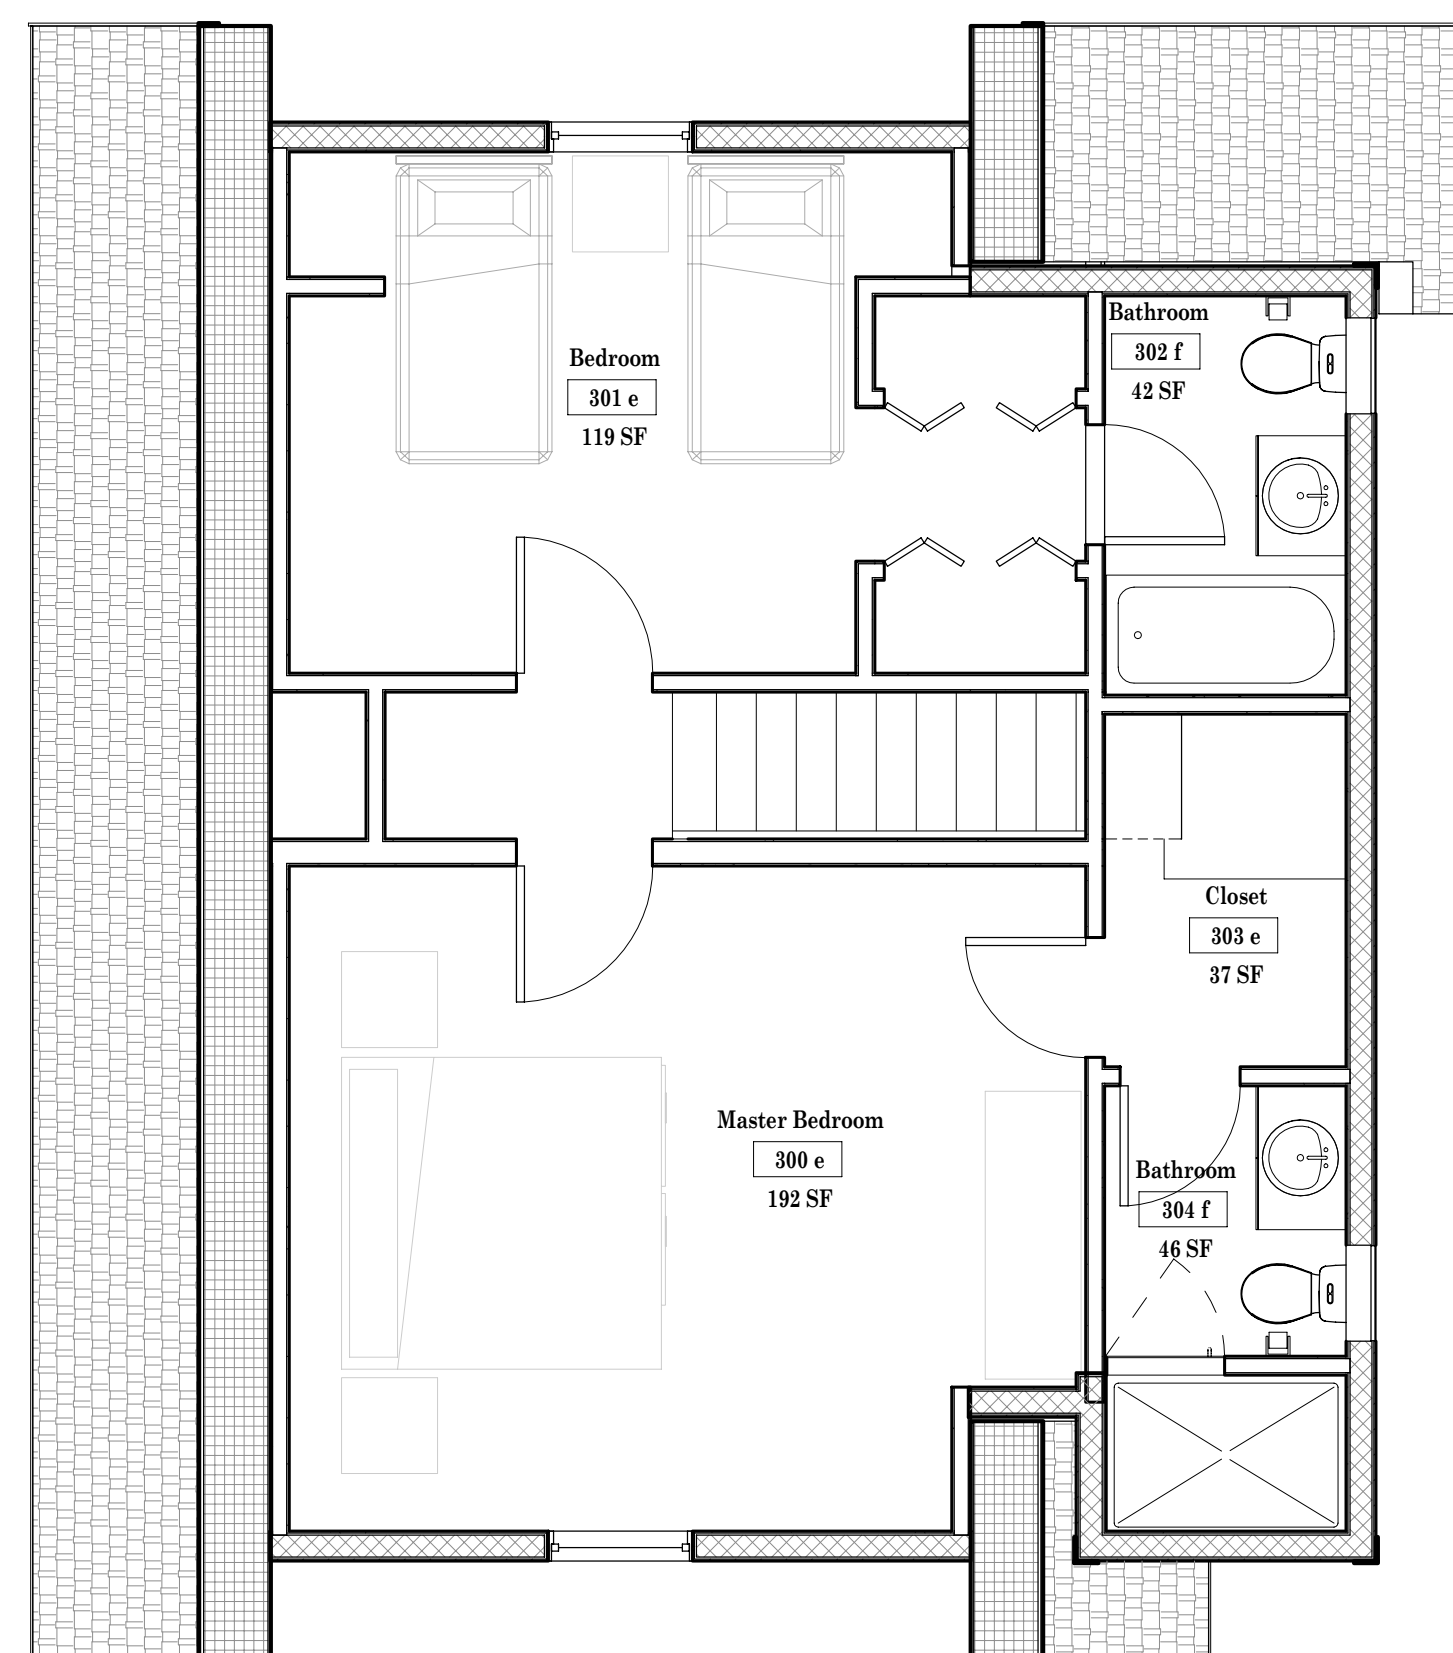

3 LEVEL 3
SCALE: 1/4" = 1'-0"

LEGEND

- 11 WALL TAG; REFER TO ARCHITECTURAL DRAWING SUPPLEMENT FOR DESCRIPTION OF CONSTRUCTION
- 11 WINDOW TAG; SEE ARCHITECTURAL DRAWING SUPPLEMENT FOR WINDOW SCHEDULE AND DETAILS
- 101 DOOR TAG; SEE ARCHITECTURAL DRAWING SUPPLEMENT FOR DOOR SCHEDULE AND DETAILS
- Room name
- 101.a ROOM NAME AND NUMBER INTERIOR FINISHES
- ELEVATION INDICATOR (REFERENCE DATUM)

GENERAL NOTES

1. FOR ENLARGED PLANS, DETAILS, AND SCHEDULES, REFER TO THE FOLLOWING SHEETS.

BATHROOMS:	AE-401 AND AE-402
KITCHENS:	AE-401 AND AE-402
BUILT-IN CABINETRY	ARCH DRAWING SUPPLEMENT
WALL TYPES AND DETAILS	ARCH DRAWING SUPPLEMENT
SCHEDULES	ARCH DRAWING SUPPLEMENT
WINDOWS AND DOORS	ARCH DRAWING SUPPLEMENT
STAIRS	ARCH DRAWING SUPPLEMENT
2. UNLESS NOTED OTHERWISE, DIMENSIONS ARE TO CENTERLINE OF DOORS AND WINDOWS, AND FACE OF CONCRETE, WALL PANELS, TOP OF SHEATHING AND VERTICAL DIMENSION LUMBER STUDS).
3. ALIGN VERTICAL WALL PANELS AND CONCRETE.
4. PROVIDE BLOCKING OR OTHER APPROVED METHOD OF SUPPORT AT ALL WALL FACE LOCATIONS FOR TV OUTLET FOR ACCOMMODATION OF FLAT PANEL FIXTURES. COORDINATE WITH INTERIOR ELEVATIONS AND ELECTRICAL PLANS.
5. COORDINATE KITCHEN CABINETRY AND APPLIANCE PLANS WITH MECHANICAL, PLUMBING AND ELECTRICAL DRAWINGS.

Revision Schedule		
No.	Date	Description
1	03-20-09	PCMC Review Comments

CONSULTANTS

BHB Consulting Engineers
Colvin Engineering Associates
BNA Consulting



ELLIOTT WORKGROUP
architecture
Park City • Sandy

449 Main Street PO Box 3419 Park City, Utah 84060 801.415.1839 fax 435.649.7127 www.elliottworkgroup.com	8706 South 700 East, Suite 201 Sandy, Utah 84070 801.415.1839 fax 801.566.5034 info@elliottworkgroup.com
---	---

DATE: February 05, 2009
ISSUE: Permit Set
PROJECT: 2007-34
DESIGNED BY: CElliott
DRAWN BY: JKlein
REVIEWED BY: RDurst

Snow Creek Cottages
ELK unit

2061 Park Avenue
Park City, Utah 84068

FLOOR PLANS

